



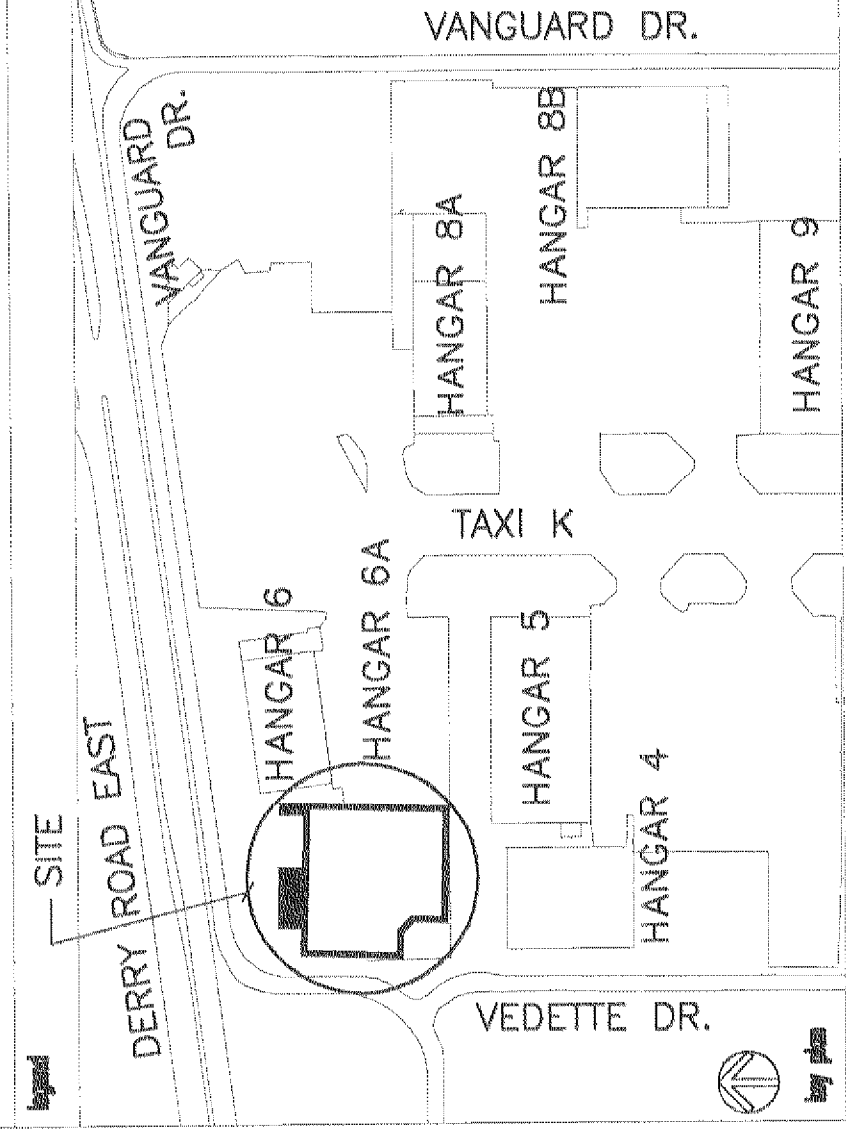


Greater Toronto Airports Authority

Technical Data Centre

1:10000

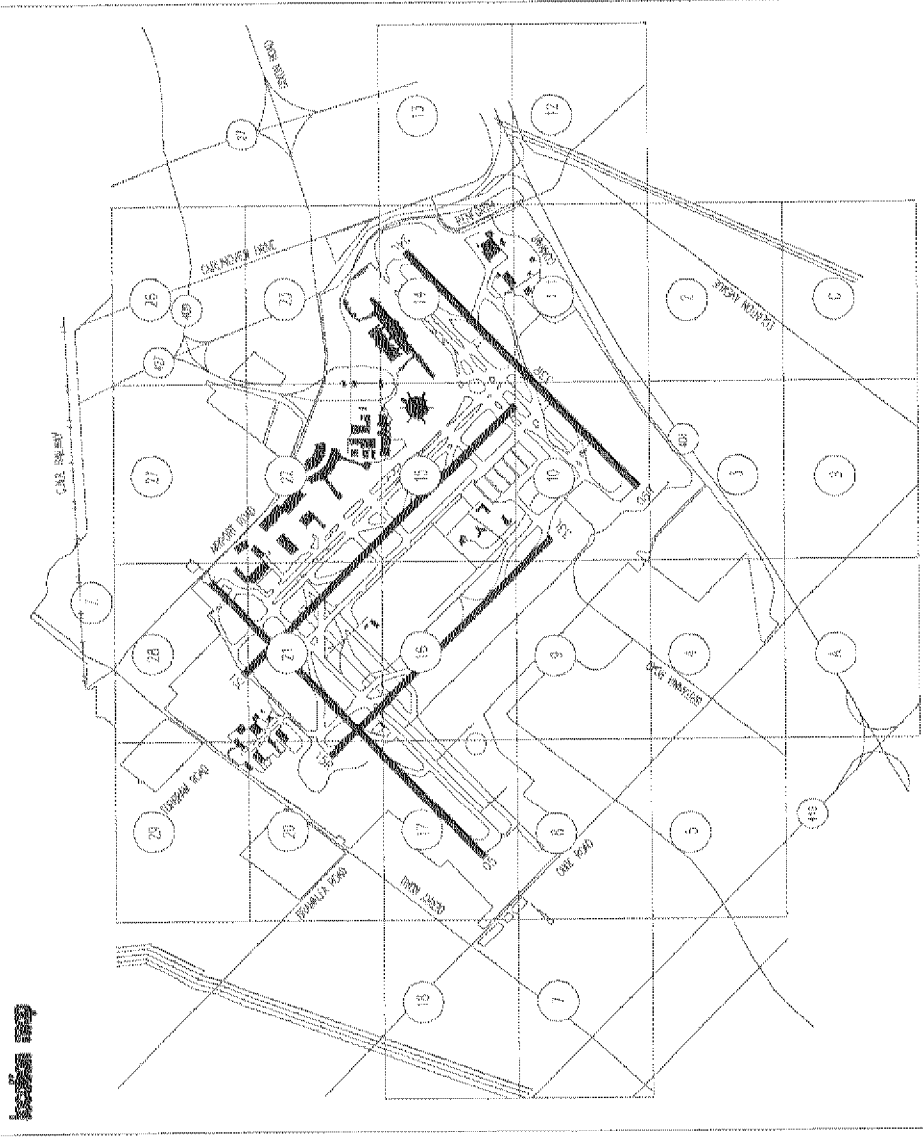

NO.	REV.	DATE	BY	CHKD.	DESCRIPTION
1	AS	09/11/04	AS	AS	ISSUED FOR CONSTRUCTION

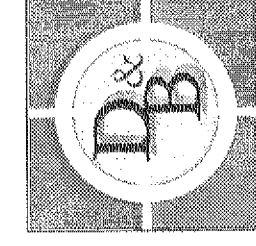

Day & Behn Engineering Inc.

Mechanical and Electrical Consulting Engineers  
5109 Steeles Avenue West, Suite 208, Weston, Ontario M9J 2Y8  
Tel: (416) 741-6131 Email: admin@daybehn.com  
Fax: (416) 741-5576 Website: http://www.daybehn.com

CALICO  
When using "AS-BUILT" Engineering Services or other services derived from a project, the user shall be responsible for any errors or omissions in the design or construction of the project. The user shall be responsible for any errors or omissions in the design or construction of the project.

TORONTO PEARSON INTERNATIONAL AIRPORT

SKYSERVICE AIRLINES HANGAR 6A PUMPROOM AND RESERVOIR ADDITION


MECHANICAL SITE PLAN

AS NOTED

DESIGNED BY	KB	REVIEWED BY	WCB
DRAWN BY	KB	DATE	—
CHECKED BY	—	SCALE	—

DATE	April 30, 2004	NO.	M1	OF	3
Y	Y	Z			

10 11 12 13 14 15 16 17 18 19 10 acres

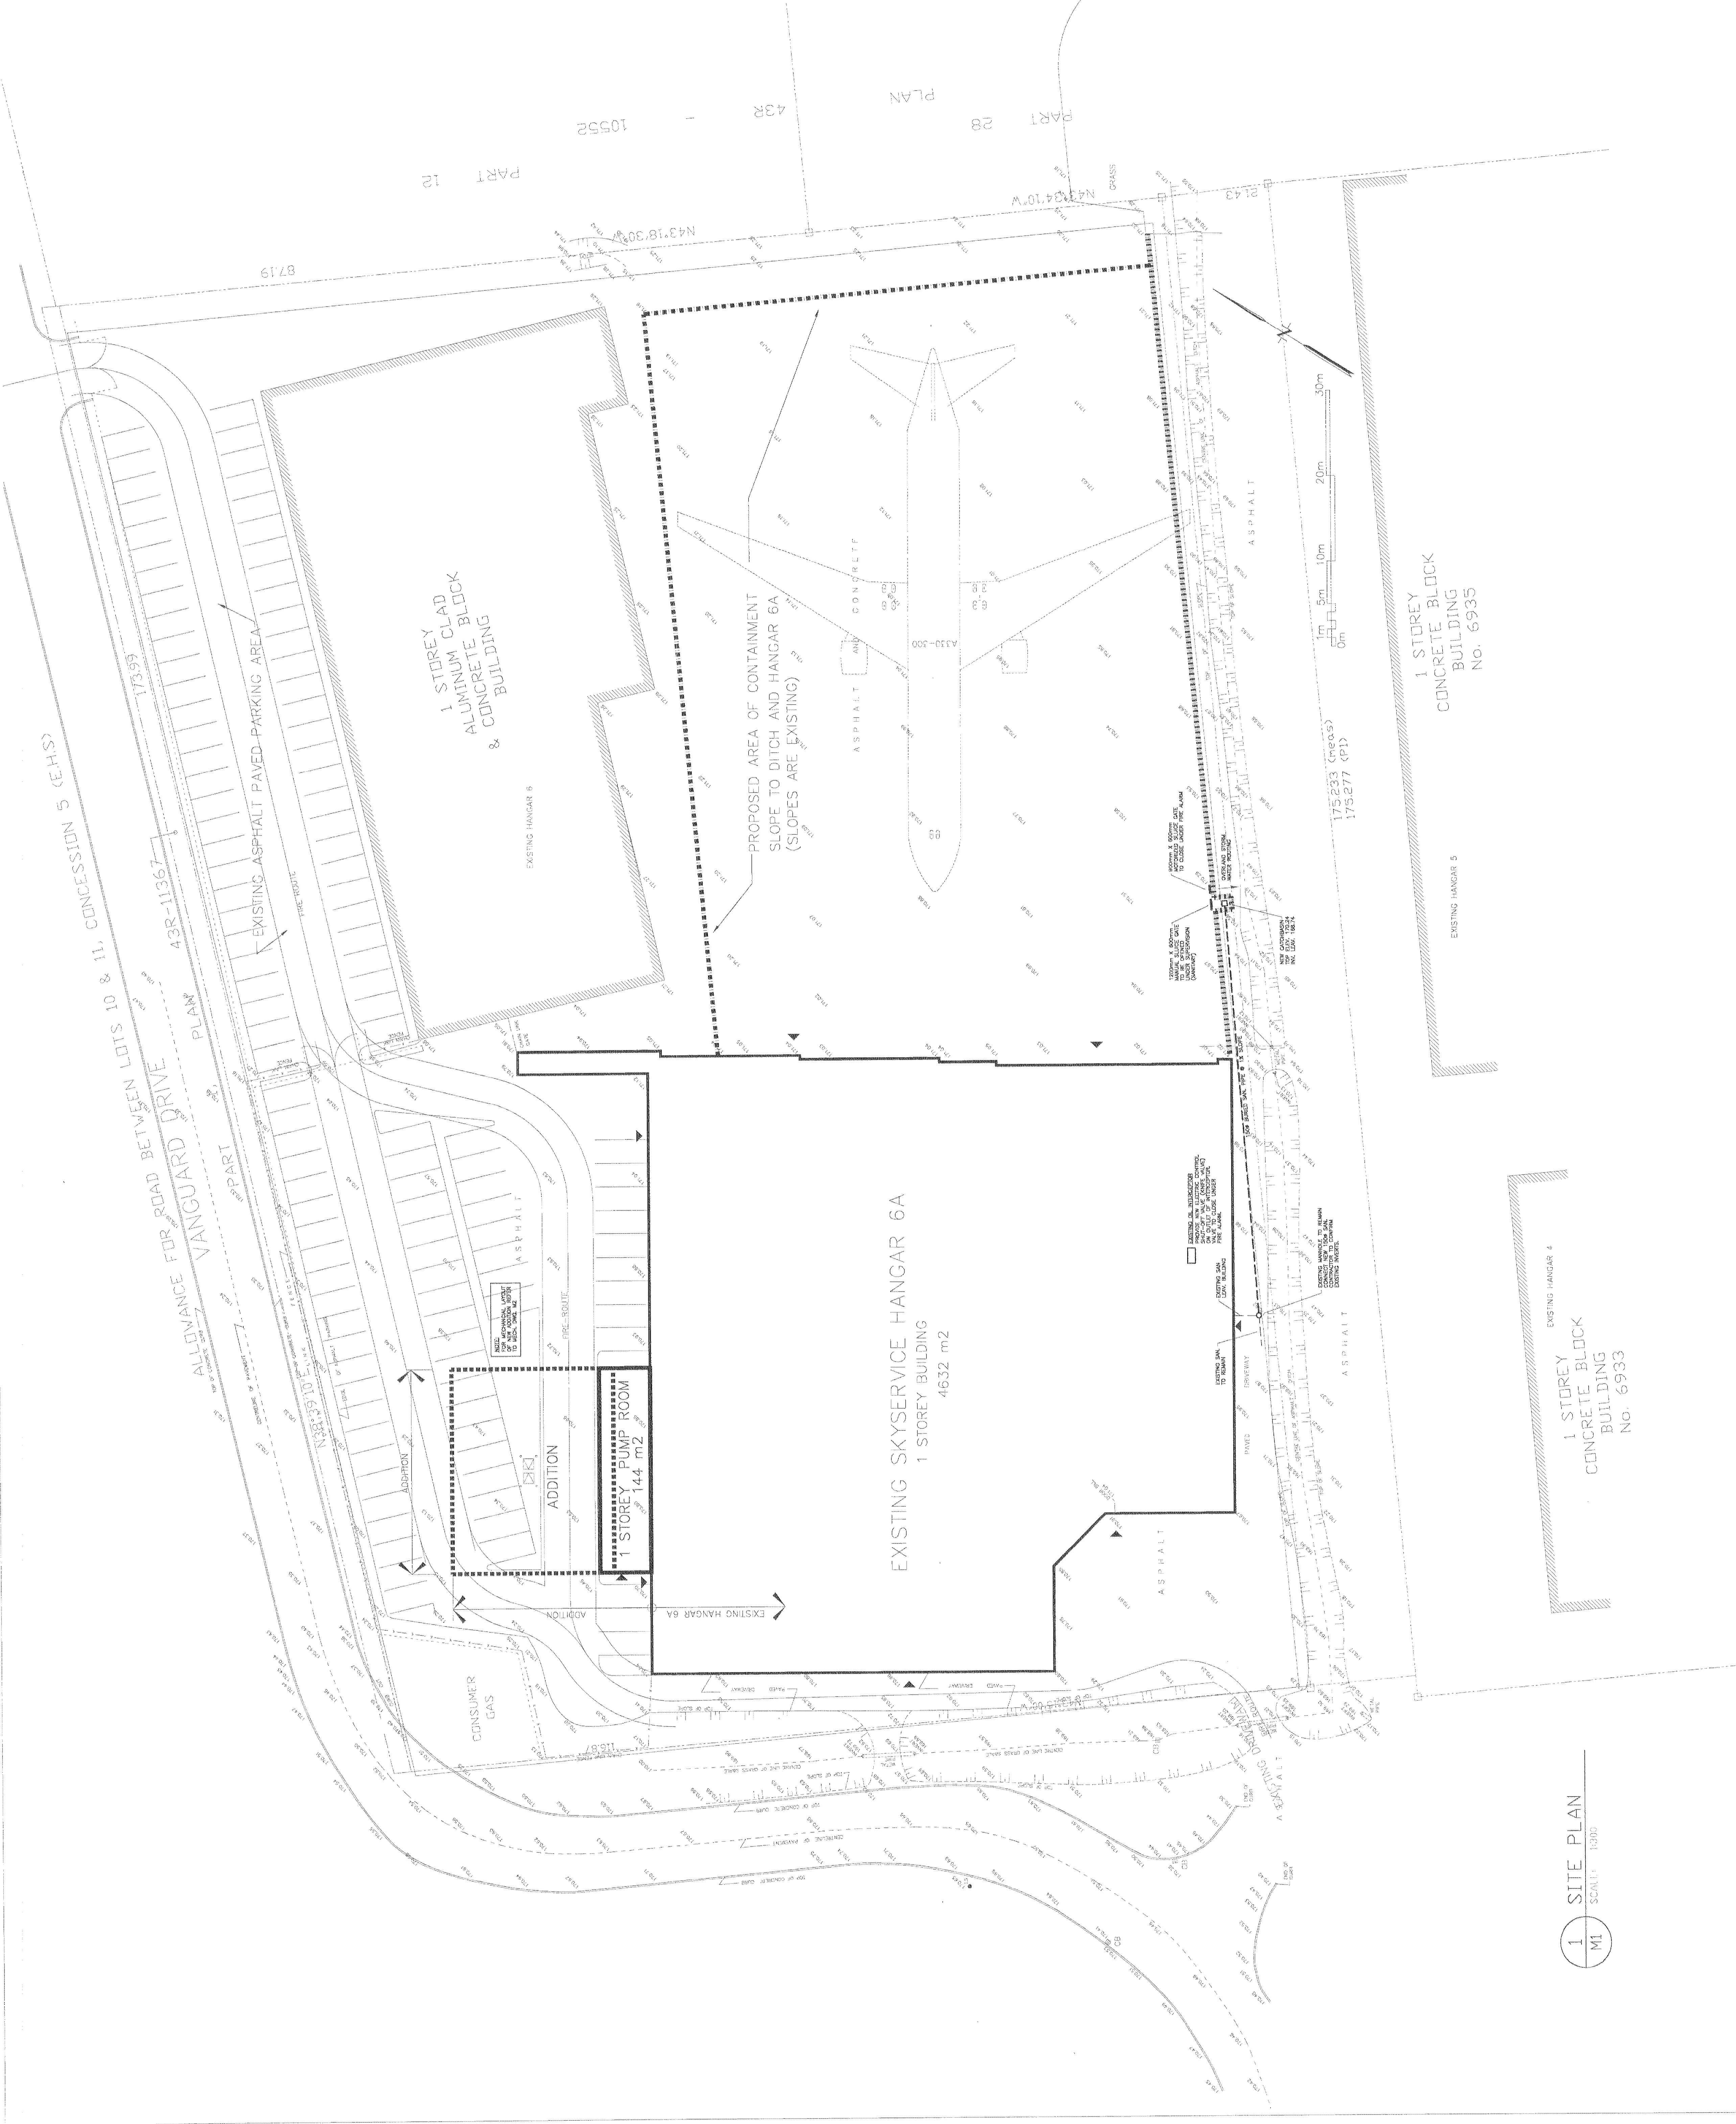

1 SITE PLAN  
SCALE: 1:1000